



**Proposals For The Site**


Scale 1:1000 @ A1

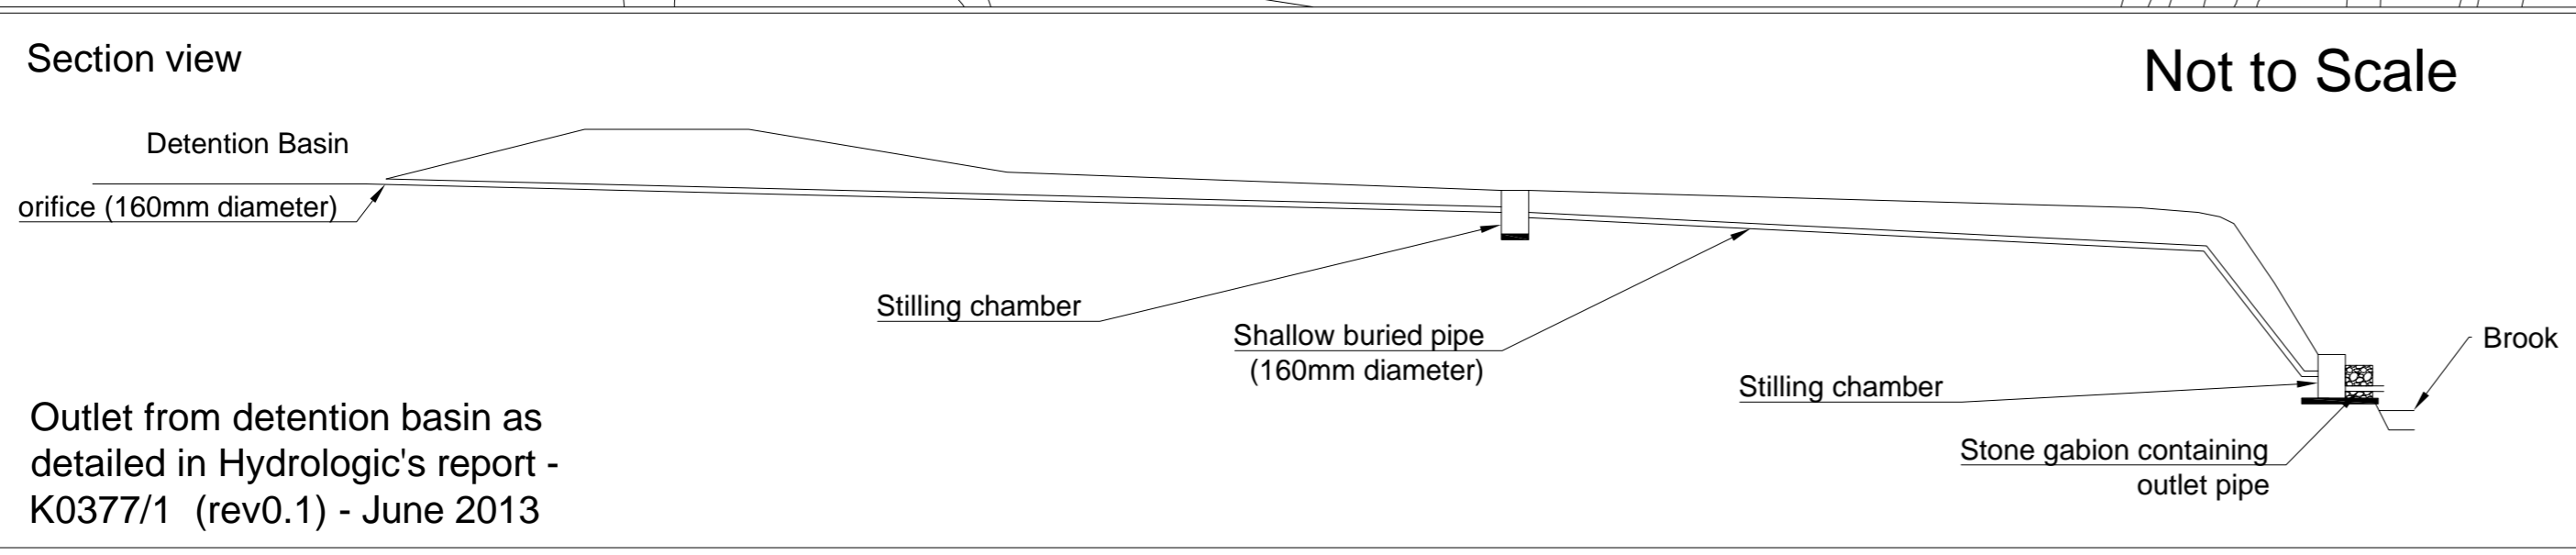

Outlet from detention basin as detailed in Hydrologic's report - K0377/1 (rev0.1) - June 2013

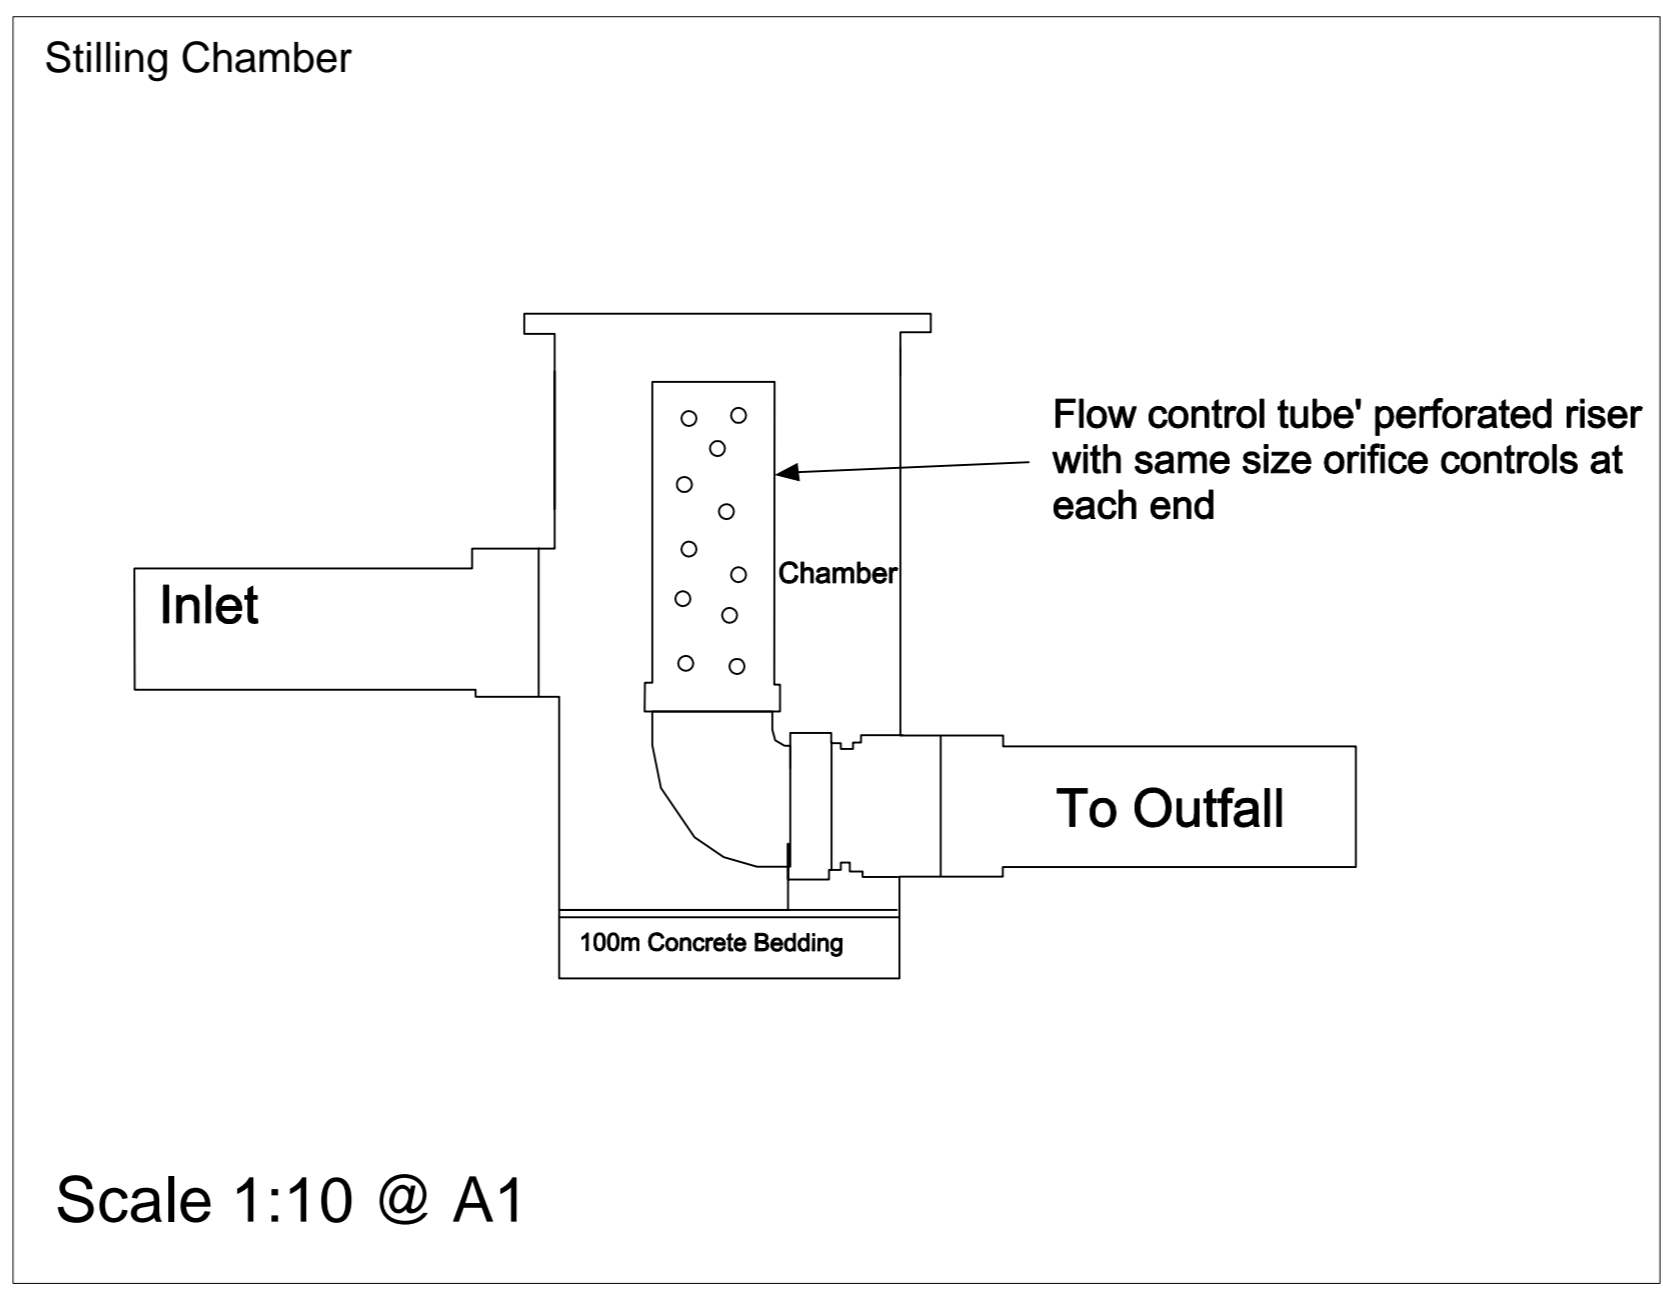

Scale 1:10 @ A1

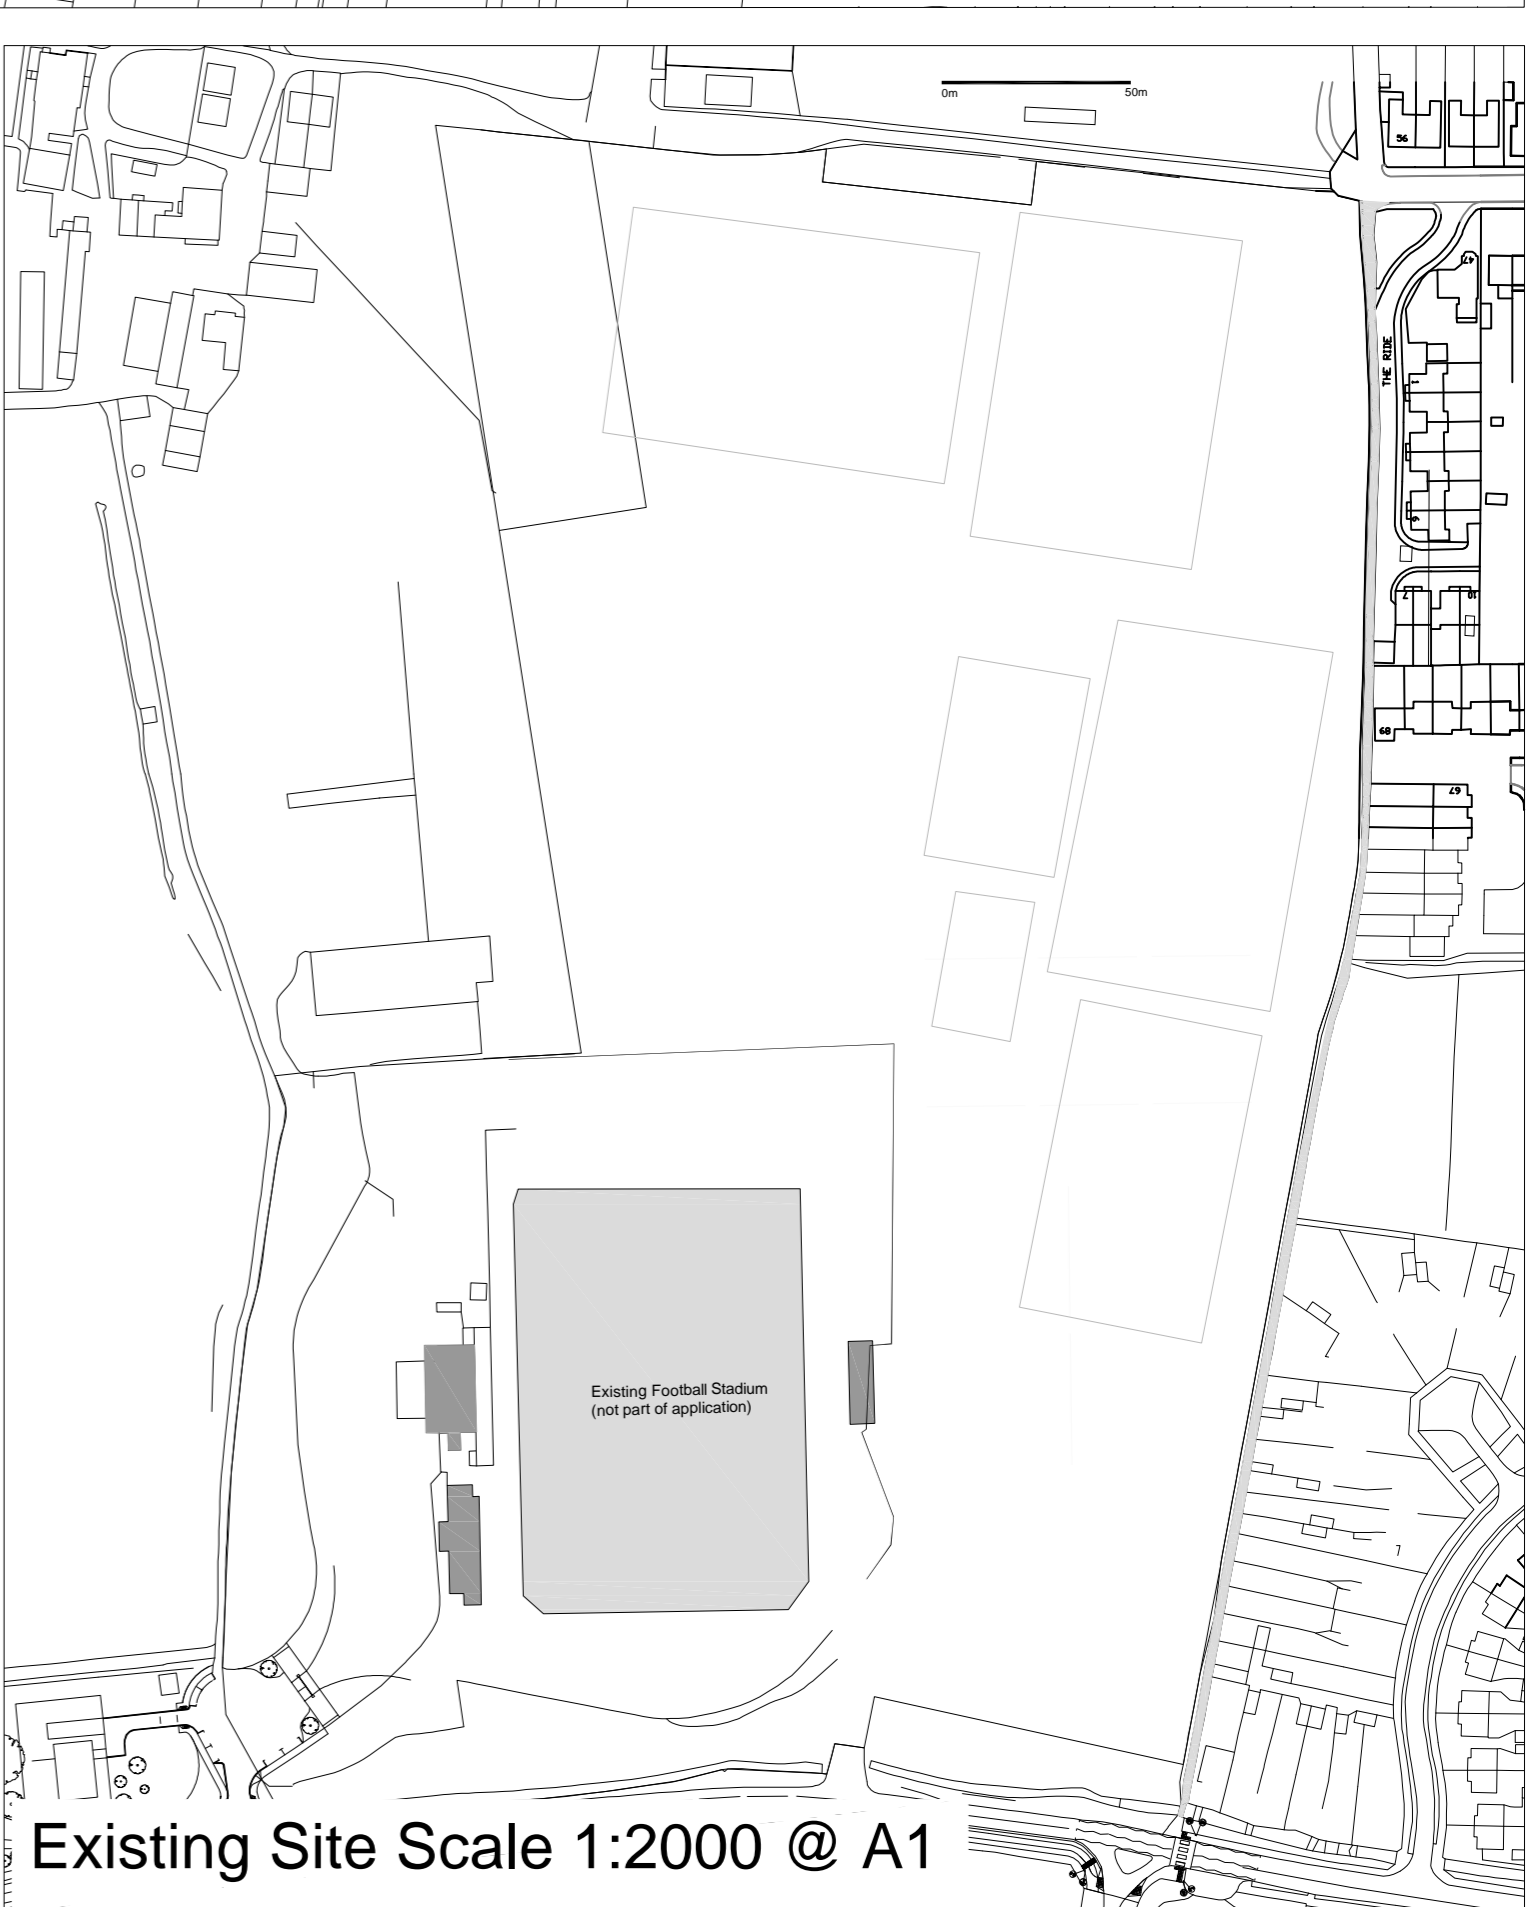

Existing Site Scale 1:2000 @ A1

**Key:**

- Swale Location For Runoff (see Hydrologic Report - section 4.3.2)
- Central Site Drainage Pipe
- Main drain line (160mm diameter solid UPVC pipe)
- Lateral drain line (80mm diameter slotted UPVC pipe)

**PEARL**

Hugh Pearl (Land Drainage) Ltd  
 New Farm  
 Bobbingworth  
 Ongar  
 Essex CM5 0DJ  
 01277 890274 tel  
 01277 890322 fax  
 email: admin@hughpearl.co.uk  
 www.hughpearl.co.uk

Project Name: Cheshunt Football Club	Drawing Name: Drainage Plan	Revisions: A - 28/11/14 - Addition of long section and stilling chamber drawing	
Project No: P377	Drawing No: P377-01	B - 8/1/15 - Inclusion of central site drainage pipe	
Drawn By: RW	Date: 17/04/2014	Checked By:	
Client: Cheshunt FC	Scale: 1:1000 @ A1	Notes: Drainage is to be determined and implemented on site by an experienced drainage contractor	